


Imperial Community College District

Educational Master Plan

2009 – 2010

Appendix F

Ten-Year Facilities Plan

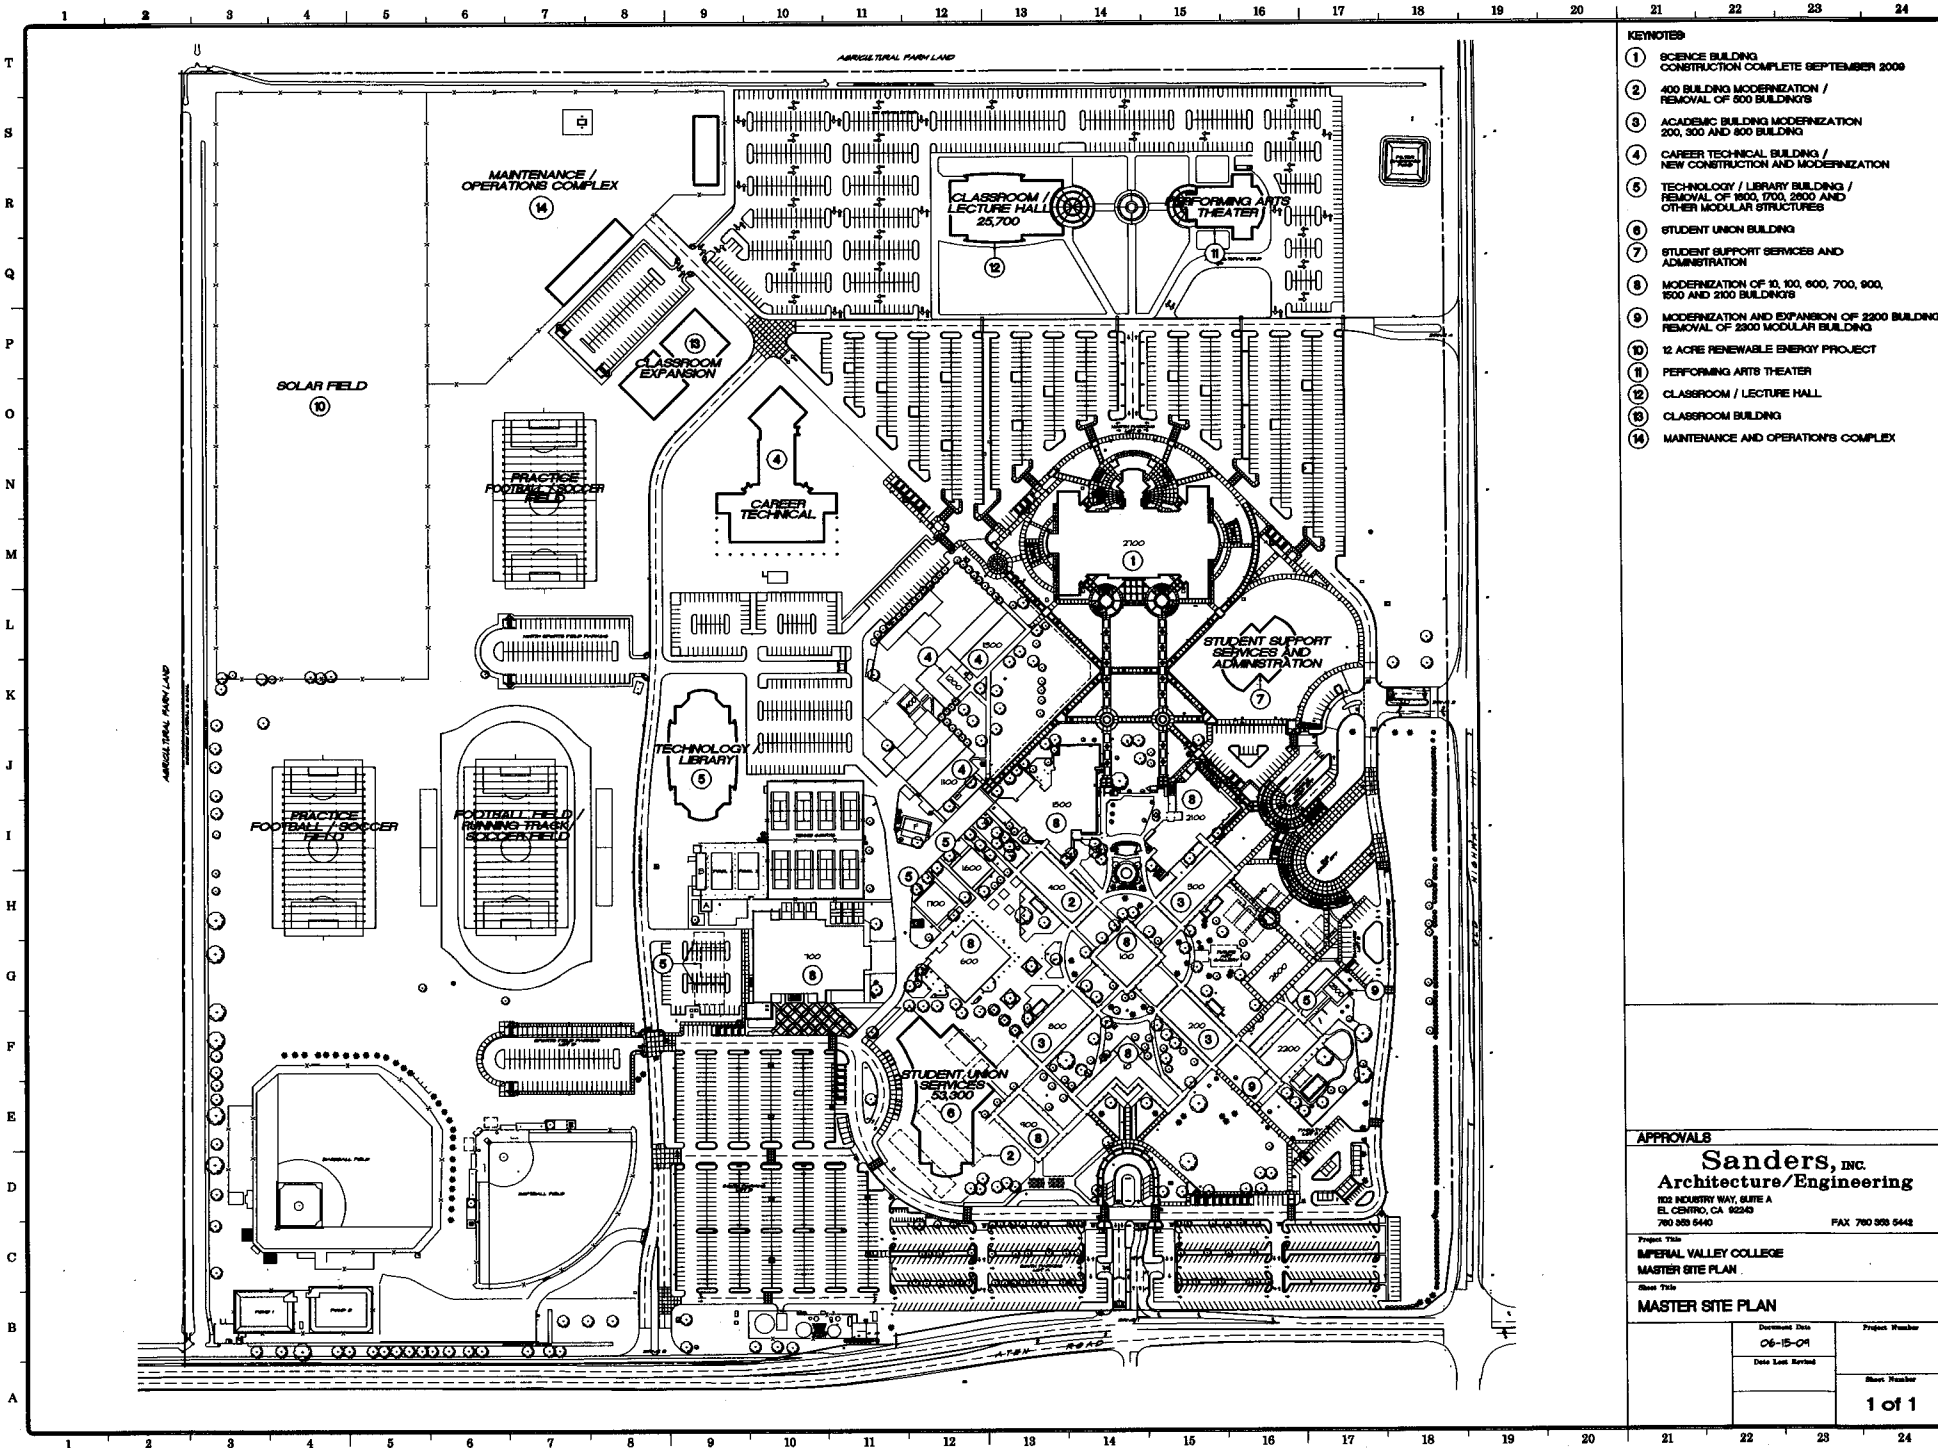

- KEYNOTES**
- 1 SCIENCE BUILDING
CONSTRUCTION COMPLETE SEPTEMBER 2009
 - 2 400 BUILDING MODERNIZATION /
REMOVAL OF 500 BUILDINGS
 - 3 ACADEMIC BUILDING MODERNIZATION
200, 300 AND 800 BUILDING
 - 4 CAREER TECHNICAL BUILDING /
NEW CONSTRUCTION AND MODERNIZATION
 - 5 TECHNOLOGY / LIBRARY BUILDING /
REMOVAL OF 1600, 1700, 2600 AND
OTHER MODULAR STRUCTURES
 - 6 STUDENT UNION BUILDING
 - 7 STUDENT SUPPORT SERVICES AND
ADMINISTRATION
 - 8 MODERNIZATION OF 10, 100, 600, 700, 900,
1500 AND 2100 BUILDINGS
 - 9 MODERNIZATION AND EXPANSION OF 2500 BUILDING
REMOVAL OF 2800 MODULAR BUILDING
 - 10 12 ACRE RENEWABLE ENERGY PROJECT
 - 11 PERFORMING ARTS THEATER
 - 12 CLASSROOM / LECTURE HALL
 - 13 CLASSROOM BUILDING
 - 14 MAINTENANCE AND OPERATIONS COMPLEX

APPROVALS

Sanders, Inc.
Architecture/Engineering
 102 INDIAN WY, SUITE A
 EL CENTRO, CA 92540
 760 858 6440 FAX 760 858 6442

Project Title
**IMPERIAL VALLEY COLLEGE
 MASTER SITE PLAN**

Sheet Title
MASTER SITE PLAN

Drawn Date 06-15-09	Project Number
Date Last Revised 	Sheet Number 1 of 1